


**LEGEND**

- PROPOSED FINISHED GRADE ABBREVIATIONS**
- BC = BEGIN CURVE
  - BW = BACK OF WALK
  - CB = CATCH BASIN
  - CL = CENTERLINE
  - C.B. = CITY OF BAKERSFIELD
  - DWS = DESIGN WATER SURFACE
  - ELEV. EL. = ELEVATION
  - END = END CURVE
  - EP = EDGE OF PAVEMENT
  - EXT = EXISTING
  - FC = FINISHED CONCRETE
  - FL = FLOWLINE
  - GB = GRADE BREAK
  - HW = H/W
  - M = MATCH
  - MB = MANHOLE
  - RG = ROUGH GRADE
  - SD = STONE DRAIN
  - SG = SUB GRADE
  - STD = STANDARD
  - STA = STATION
  - TC = TOP OF CURB
  - TOS = TOP OF SLOPE
  - TW = TOP OF WALL
  - W = SIDEWALK

2% SLOPE IN PERCENT

**TOPOGRAPHY**

- FOUND MONUMENT AS DESCRIBED**
- EXISTING POWER POLE
  - EXISTING DOWN GUY
  - EXISTING ELECTRICAL METER
  - EXISTING TRAFFIC SIGN
  - EXISTING STREET NAME SIGN
  - EXISTING IRRIGATION VALVE OR RISER
  - EXISTING IRRIGATION STANDPIPE
  - EXISTING WATER VALVE
  - EXISTING FIRE HYDRANT
  - EXISTING WATER METER
  - EXISTING HOSE BIB
  - EXISTING WHARF HYDRANT
  - EXISTING BLOW-OFF ASSEMBLY
  - EXISTING SEWER MANHOLE
  - EXISTING SEWER CLEANOUT
  - EXISTING STORM DRAIN MANHOLE
  - EXISTING GAS VALVE
  - EXISTING PIPELINE MARKER
  - EXISTING TELEPHONE PEDESTAL
  - EXISTING TELEPHONE VAULT
  - EXISTING TRASH CANS
  - EXISTING DRAIN PIPES
  - EXISTING STREET LIGHTS
  - EXISTING WATER FOUNTAIN
- ABBREVIATIONS**
- EP = EDGE OF PAVEMENT
  - TC = TOP OF CURB
  - FL = FLOWLINE
  - CL = CENTERLINE
  - ELEV. ELEVATION
  - FC = FINISH CONCRETE
- EXISTING STREET LIGHT**
- EXISTING STREET LIGHT PULL BOX
  - EXISTING CABLE T.V. VAULT
  - EXISTING TREE, DECIDUOUS, EVERGREEN, PALM, SHRUB
  - SURVEY ELEVATION
  - EXISTING SEWER LINE
  - EXISTING STORM DRAIN LINE
  - EXISTING WATER LINE
  - EXISTING TELEPHONE LINE
  - EXISTING GAS LINE
  - EXISTING UTILITY TRENCH
  - EXISTING EDGE OF PAVEMENT
  - EXISTING CHAIN LINK FENCE
  - EXISTING BARB WIRE FENCE
  - EXISTING GROUND CONTOUR
  - EXISTING CURB AND GUTTER
  - EXISTING PROPERTY LINE
  - EXISTING NO. 5 PULL BOX
  - EXISTING TRAFFIC SIGNAL CONTROLLER
  - EXISTING MAST ARM TRAFFIC SIGNAL
  - TRAFFIC SIGNAL
  - PEDESTRIAN HEAD
- DETAIL DESIGNATION**
- CITY STANDARD DESIGNATION
  - INDICATES REFERENCED CITY OF BAKERSFIELD STANDARD
- SECTION DESIGNATION**
- SECTION LETTER
  - SHEET WHERE SECTION IS SHOWN

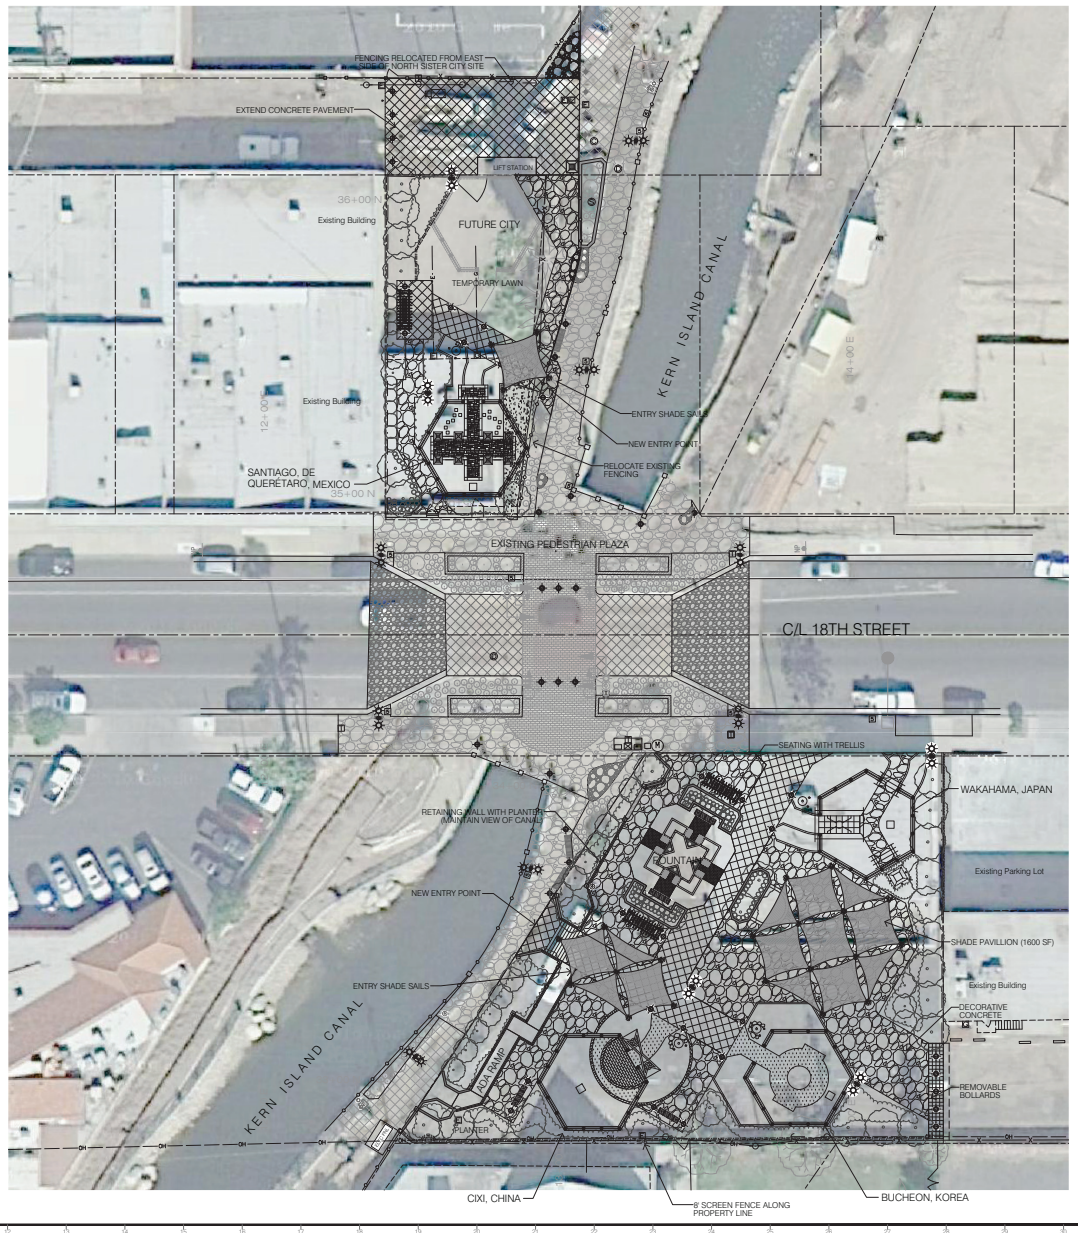

DATE: 11/19/10

DRAWN BY: [Signature]

CHECKED BY: [Signature]

DESIGNED BY: [Signature]

SCALE: AS SHOWN

PROJECT NO: 08-00000000

SHEET NO: 10

CITY OF BAKERSFIELD MILL CREEK LINEAR PARK  
SISTER CITY ANNEX  
SITE PLAN

Meyer Engineering, Inc.  
 Civil Engineering, Inc.  
 110 S. Main Street, Ste. 104, Bakersfield, CA 93301  
 Phone: 805-438-9924  
 Fax: 805-438-9919